

REVISIONS	BY
CHANGE OCCUPANCY 2/18/08	BES

Brent Stewart, P.E.
Consulting Engineer
 PO Box 3116, Diamond Springs, CA 95619
 530-621-0300 FAX 530-621-0900

AIM HIGHER
ADULT DAY PROGRAM
3151 DWIGHT RD. #400
ELK GROVE, CA - BLDG. 5

ROOF
ELECT.

DRAWN :
 BES

CHECKED :
 BES


DATE: 2/18/08

SCALE: AS NOTED

JOB NO.: 2207

SHEET


E4

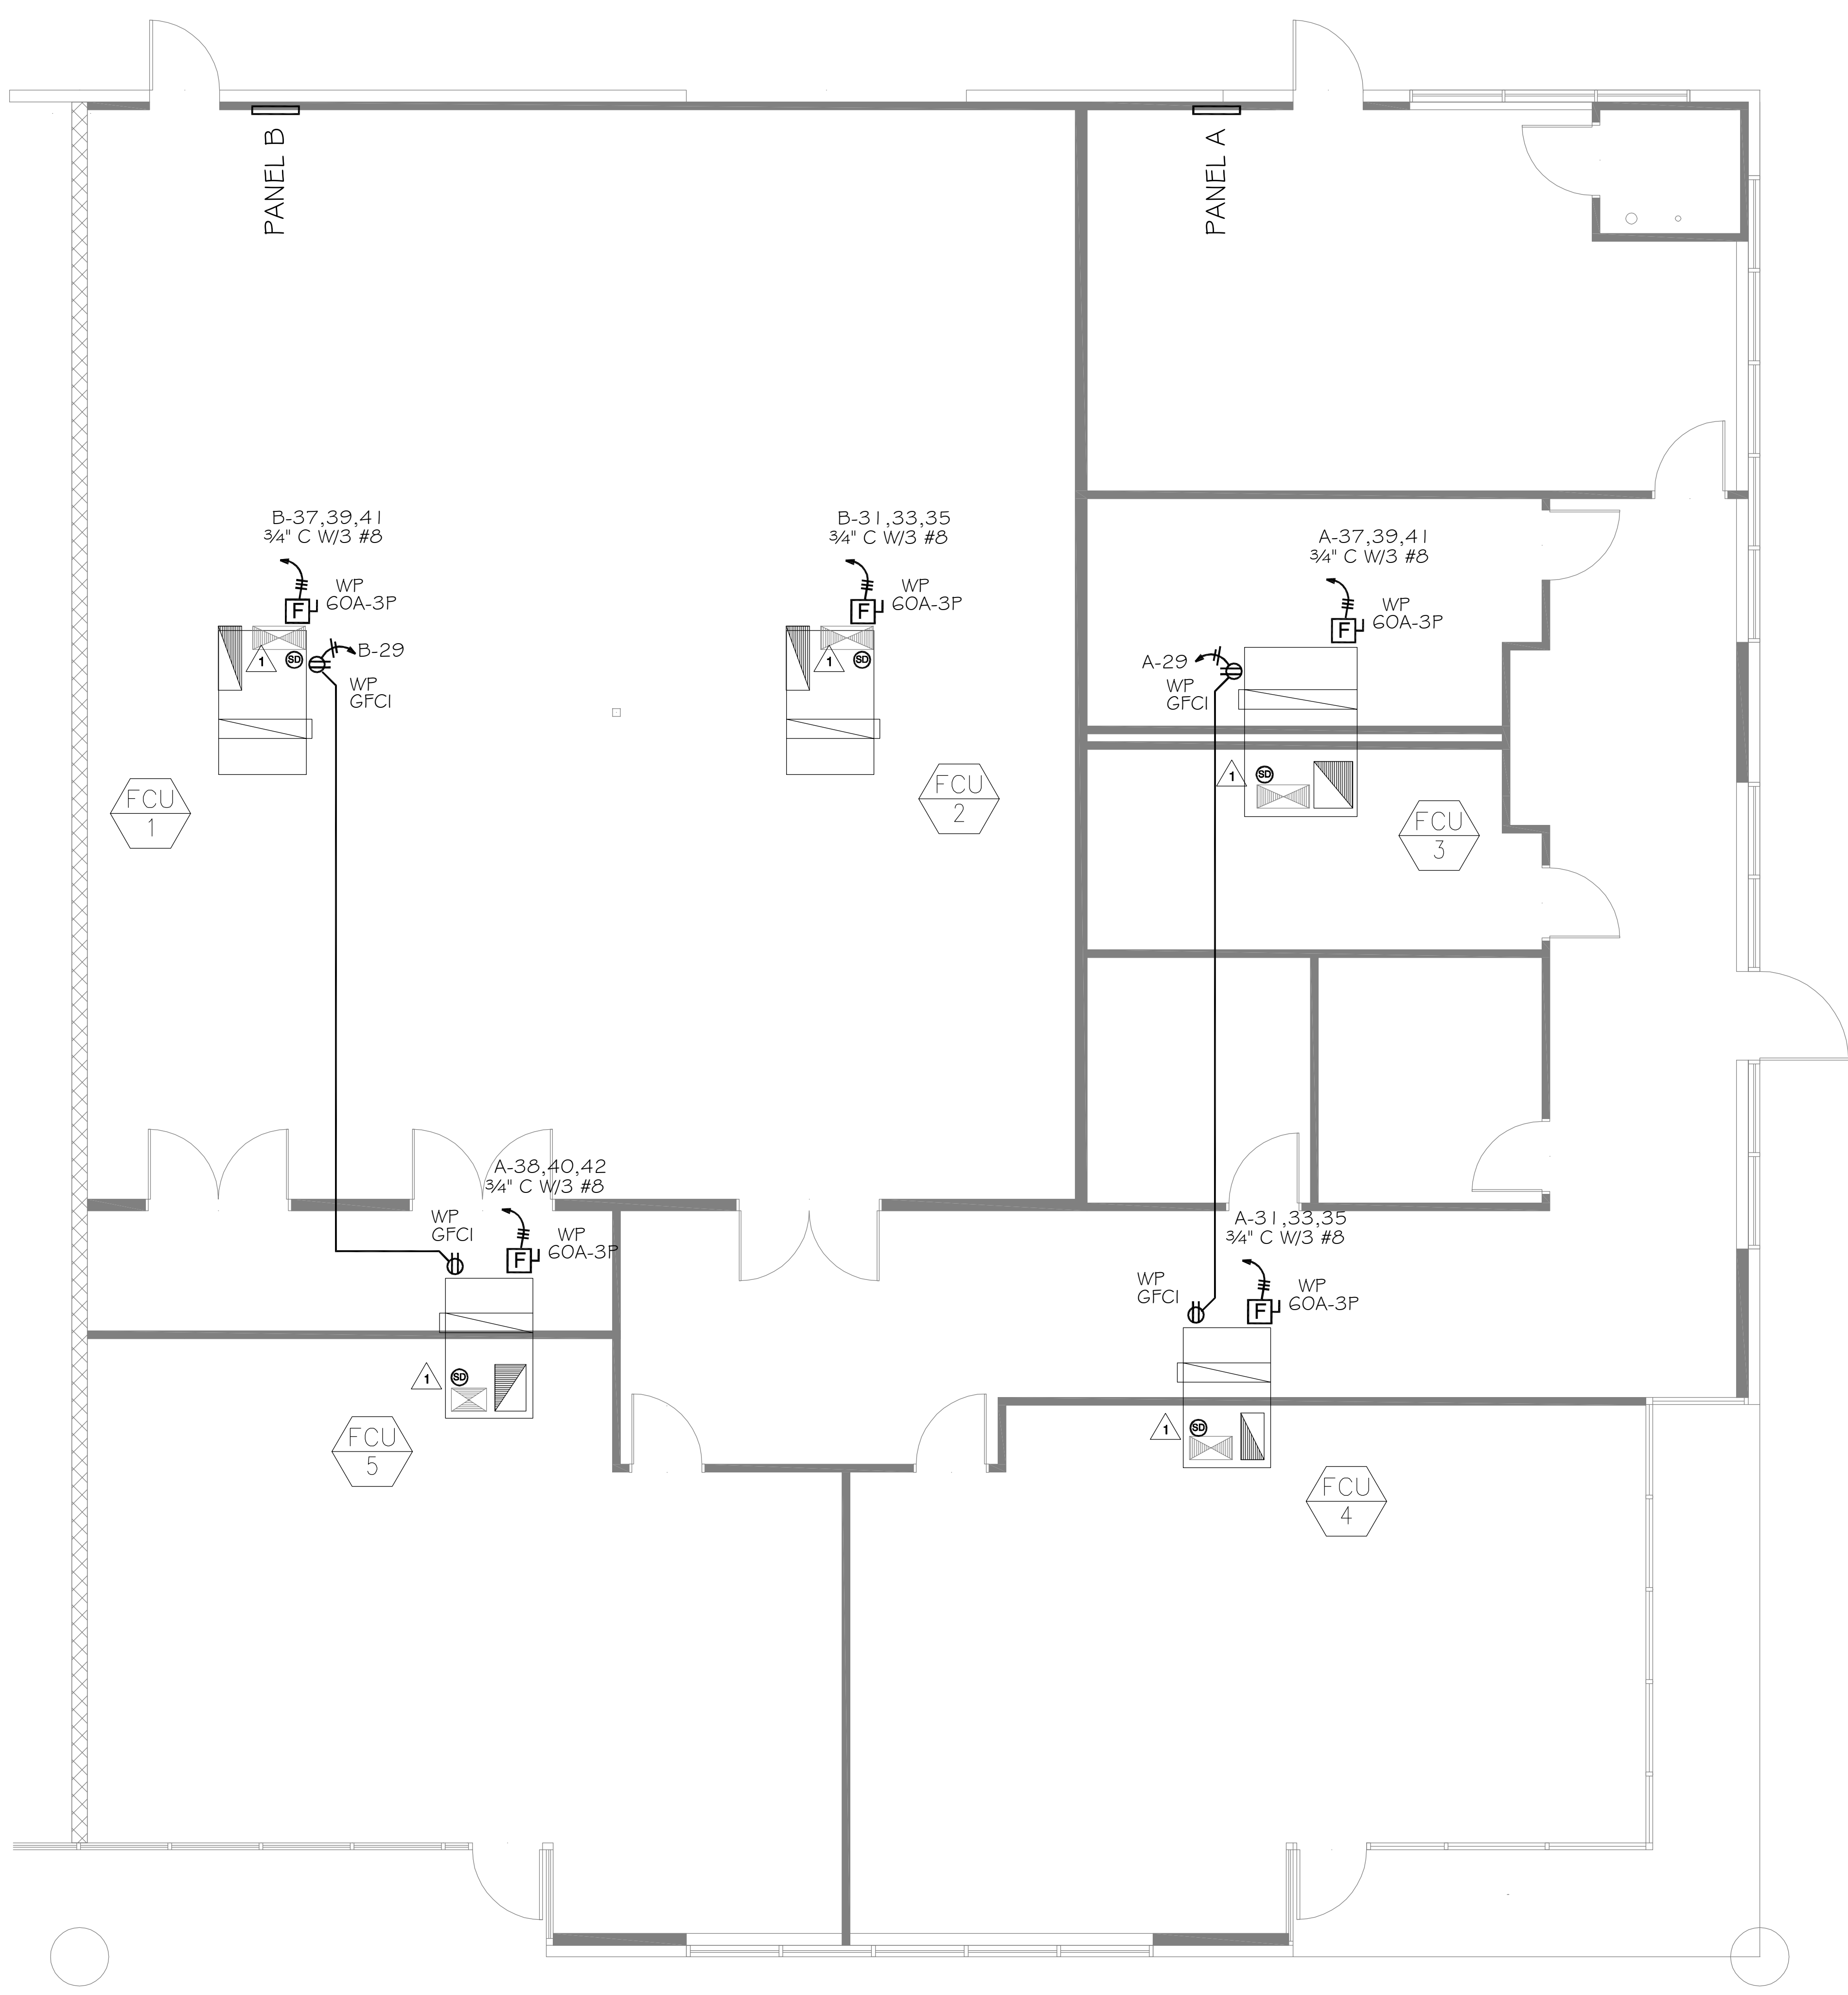

LEGEND		
	LAY-IN FLUORESCENT LIGHT FIXTURE SEE FIXTURE SCHEDULE FOR # OF LAMPS	\$ SINGLE POLE TOGGLE SWITCH MOUNT +42" UNLESS NOTED
	LAY-IN FLUORESCENT FIXTURE WITH INTEGRAL BATTERY PACK FOR EMERGENCY OPERATION	⊕ JUNCTION BOX SIZE AS NECESSARY
	SURFACE MOUNTED FLUORESCENT FIXTURE - SEE FIXTURE SCHEDULE FOR # OF LAMPS	⊙ EXHAUST FAN - SEE MECHANICAL PLAN FOR DETAILS
	LED EXIT LIGHT WITH INTEGRAL BATTERY AND EMERGENCY LIGHTING. WALL MOUNTED WITH ARROWS AS SHOWN	▲ TELEPHONE AND NETWORK OUTLET CONTRACTOR TO FURNISH 4" BOX WITH SINGLE-GANG MUD RING AND FULL STRING. TENANT TO INSTALL CABLE AND WALL PLATE. INSTALL HEIGHT +18" UNLESS NOTED.
	LED EXIT LIGHT WITH INTEGRAL BATTERY AND EMERGENCY LIGHTING. WALL MOUNTED WITH ARROWS AS SHOWN	⊠ 4" X 4" OR LARGER J-BOX WITH 2" CONDUIT AND PULLSTRING INTO INTERSTITIAL SPACE FOR NETWORK WIRING. INSTALL HEIGHT +18" UNLESS NOTED.
	RECESSED LIGHT - SEE FIXTURE SCHEDULE FOR COMPLETE DESCRIPTION	Ⓜ TTB TELEPHONE TERMINAL BOARD. 4" X 8" X 3/4" PLYWOOD W/DUPLEX RECEPTACLE #6 GROUND
	SURFACE OR HANGING FIXTURE - SEE FIXTURE SCHEDULE FOR DESCRIPTION	Ⓜ WP GFCI 15 OR 20 AMP 125V 3 WIRE DUPLEX GFCI RECEPTACLE IN WEATHERPROOF BOX
	FIXTURE CALLOUT - SEE FIXTURE SCHEDULE FOR DESCRIPTION	Ⓜ F 15 OR 20 AMP 125V 3 WIRE DUPLEX GFCI RECEPTACLE IN WEATHERPROOF BOX
	15 OR 20 AMP 125V 3 WIRE DUPLEX RECEPTACLE. INSTALL HEIGHT +18" UNLESS NOTED.	Ⓜ F FUSED DISCONNECT SWITCH 60 A, 3 POLE UNLESS NOTED

GENERAL NOTES:

- 1 DUCT SMOKE DETECTOR, AIR PRODUCTS & CONTROLS "RW" SERIES OR EQUIVALENT.
- HVAC CONTRACTOR TO CONNECT TO 24VAC THERMOSTAT CONTROL WIRING PER MANUFACTURER'S SPECIFICATIONS. PRIMARY ALARM CONTACT TO SHUT DOWN HVAC WHEN SMOKE IS DETECTED.
- FIRE ALARM CONTRACTOR TO WIRE SECONDARY ALARM AND TROUBLE CONTACTS INTO BUILDING FIRE ALARM SYSTEM.

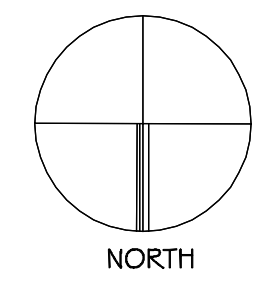

ROOF ELECTRICAL
 SCALE: 1/4" = 1'-0"

COPYRIGHT 2002
 BRENT E. STEWART, P.E.
 THESE PLANS ARE NOT TO BE REPRODUCED,
 CHANGED OR COPIED IN ANY FORM OR MAN-
 NER WHATSOEVER, NOR ARE THEY TO BE
 ASSIGNED TO ANY THIRD PARTY, WITHOUT
 FIRST OBTAINING THE EXPRESS WRITTEN
 PERMISSION AND CONSENT OF
 BRENT E. STEWART, P.E.

THE CONTRACTOR AND/OR SUB-CONTRACTOR
 SHALL VERIFY ALL DIMENSIONS ON THE
 DRAWINGS AND SHALL BE RESPONSIBLE FOR
 THEIR ACCURACY. NOTIFY THE OWNER OF
 ANY DISCREPANCIES PRIOR TO STARTING
 WORK.